


**NARRAGANSETT
INDIAN
HEALTH CENTER**

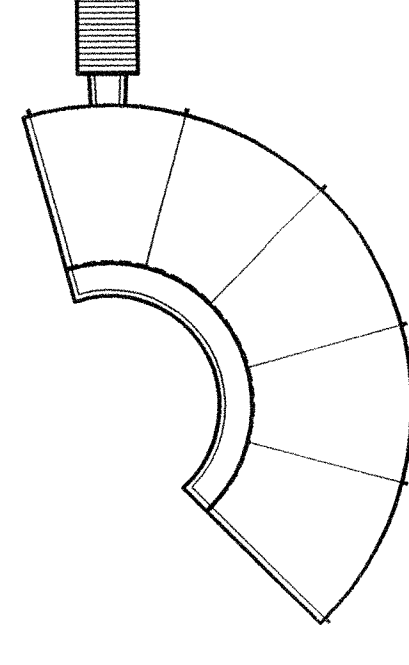


Number: M207
Issued For:

11/28/07 PERMITTING

SITE GRADING

Date: 04/25/11
Scale: 1"=20'-0"
Proj. Number: 04026.00
Drawing Number: **L301**

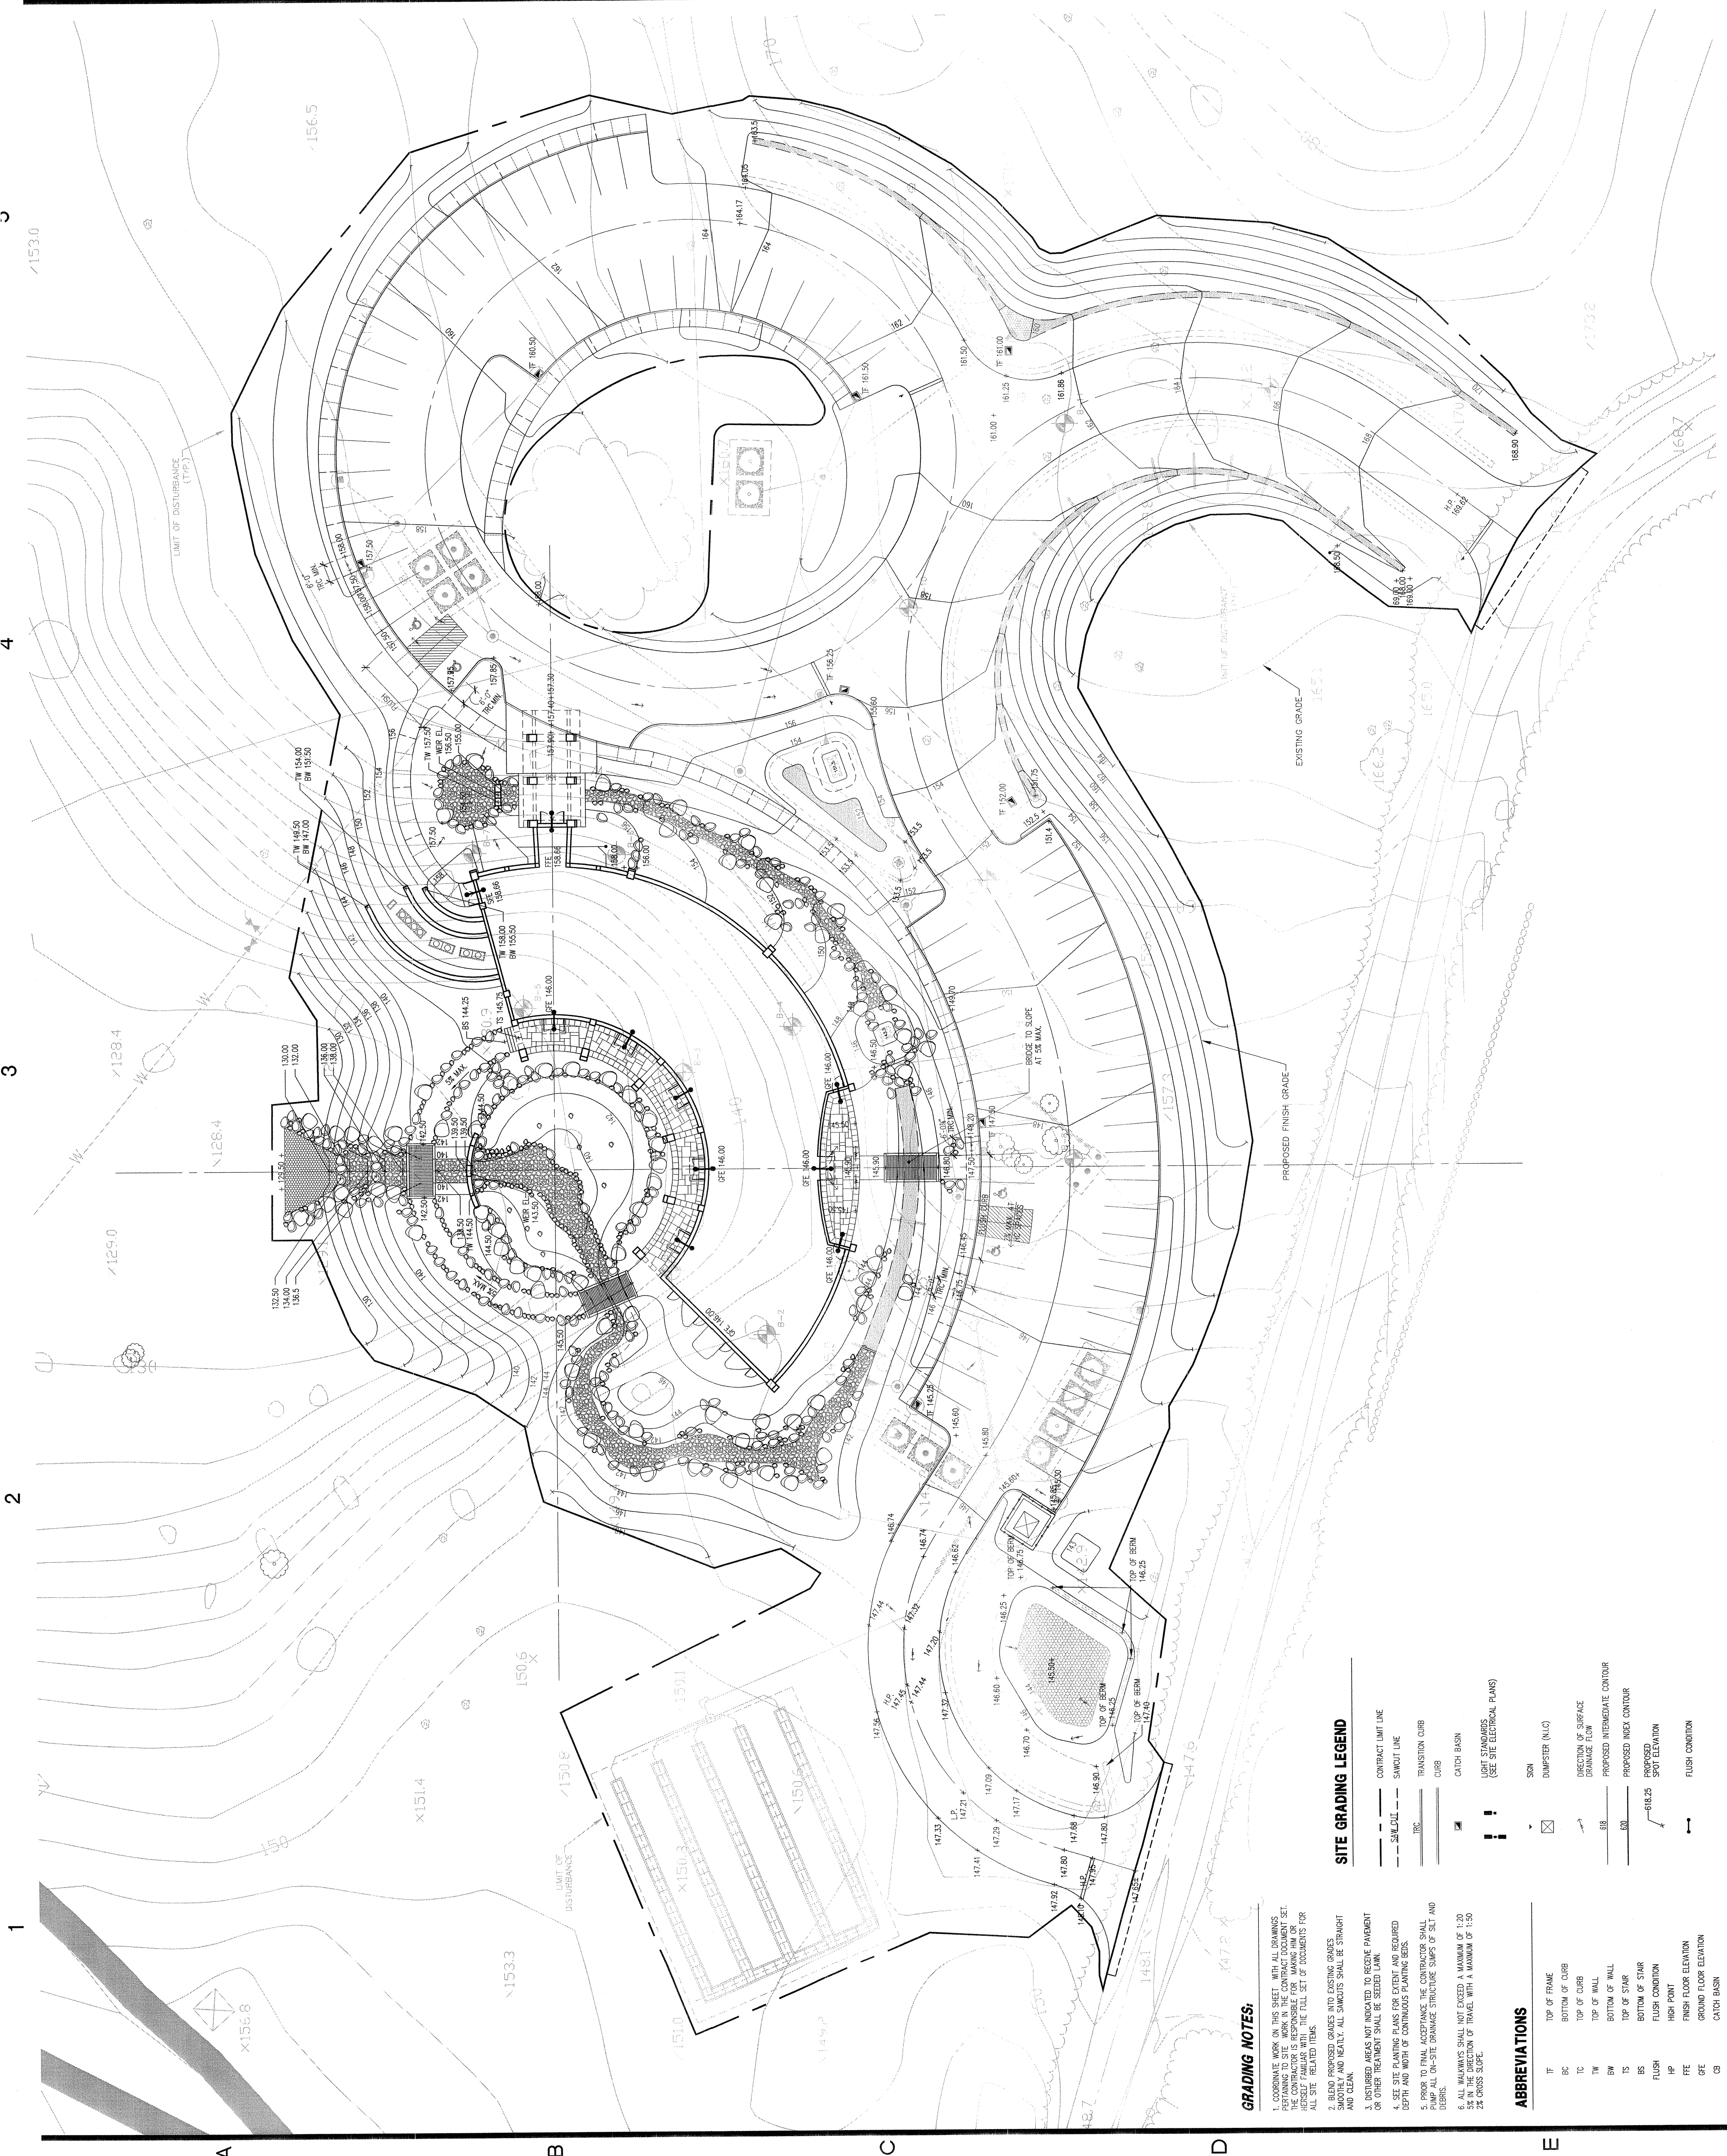

GRADING NOTES:

- COORDINATE WORK ON THIS SHEET WITH ALL DRAWINGS PERTAINING TO SITE WORK IN THE CONTRACT DOCUMENT SET. THE CONTRACTOR SHALL BE RESPONSIBLE FOR VERIFYING THE EXISTING GRADE AND VERIFYING THE FULL SET OF DOCUMENTS FOR ALL SITE RELATED ITEMS.
- BLEND PROPOSED GRADES INTO EXISTING GRADES SMOOTHLY AND NEATLY. ALL SLOPES SHALL BE STRAIGHT AND CLEAN.
- DISTURBED AREAS NOT INDICATED TO RECEIVE PAVEMENT OR OTHER TREATMENT SHALL BE SEEDED LAWN.
- SEE SITE PLANTING PLANS FOR EXTENT AND REQUIRED DEPTH AND WIDTH OF CONTIGUOUS PLANTING BEDS.
- PRIOR TO FINAL ACCEPTANCE THE CONTRACTOR SHALL PUMP ALL ON-SITE DRAINAGE STRUCTURE SUMPS UP SLOTTED DEBERS.
- ALL WALKWAYS SHALL NOT EXCEED A MAXIMUM OF 1:20 SLOPE. ALL DRIVEWAYS SHALL NOT EXCEED A MAXIMUM OF 1:20 SLOPE. ALL DRIVEWAYS SHALL BE STRAIGHT AND CLEAN.

SITE GRADING LEGEND

- CONTRACT LIMIT LINE
- SAWTOOTH LINE
- TYPICAL CURB
- CATCH BASIN
- LIGHT STANDARDS (SEE SITE ELECTRICAL PLANS)
- SIGN
- DAMPSTER (NLC)
- CURBLINE OF SURFACE DRAINAGE FLOW
- PROPOSED INTERMEDIATE CONTOUR
- PROPOSED INDEX CONTOUR
- 612.25 SPOT ELEVATION
- FLUSH CONDITION

ABBREVIATIONS

- TF TOP OF FRAME
- BC BOTTOM OF CURB
- TC TOP OF CURB
- TW TOP OF WALL
- BW BOTTOM OF WALL
- TS TOP OF STAR
- BS BOTTOM OF STAR
- FLUSH FLUSH CONDITION
- HP HIGH POINT
- FTE FINISH FLOOR ELEVATION
- GFE GROUND FLOOR ELEVATION
- CB CATCH BASIN